

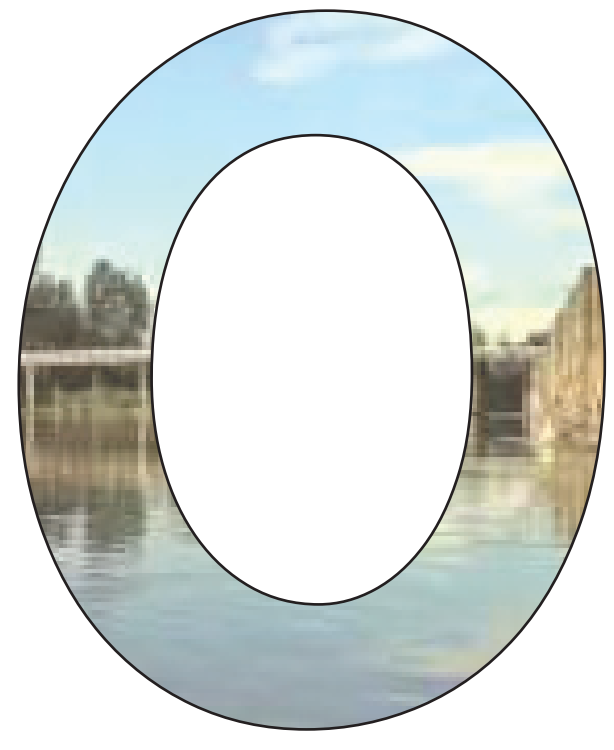


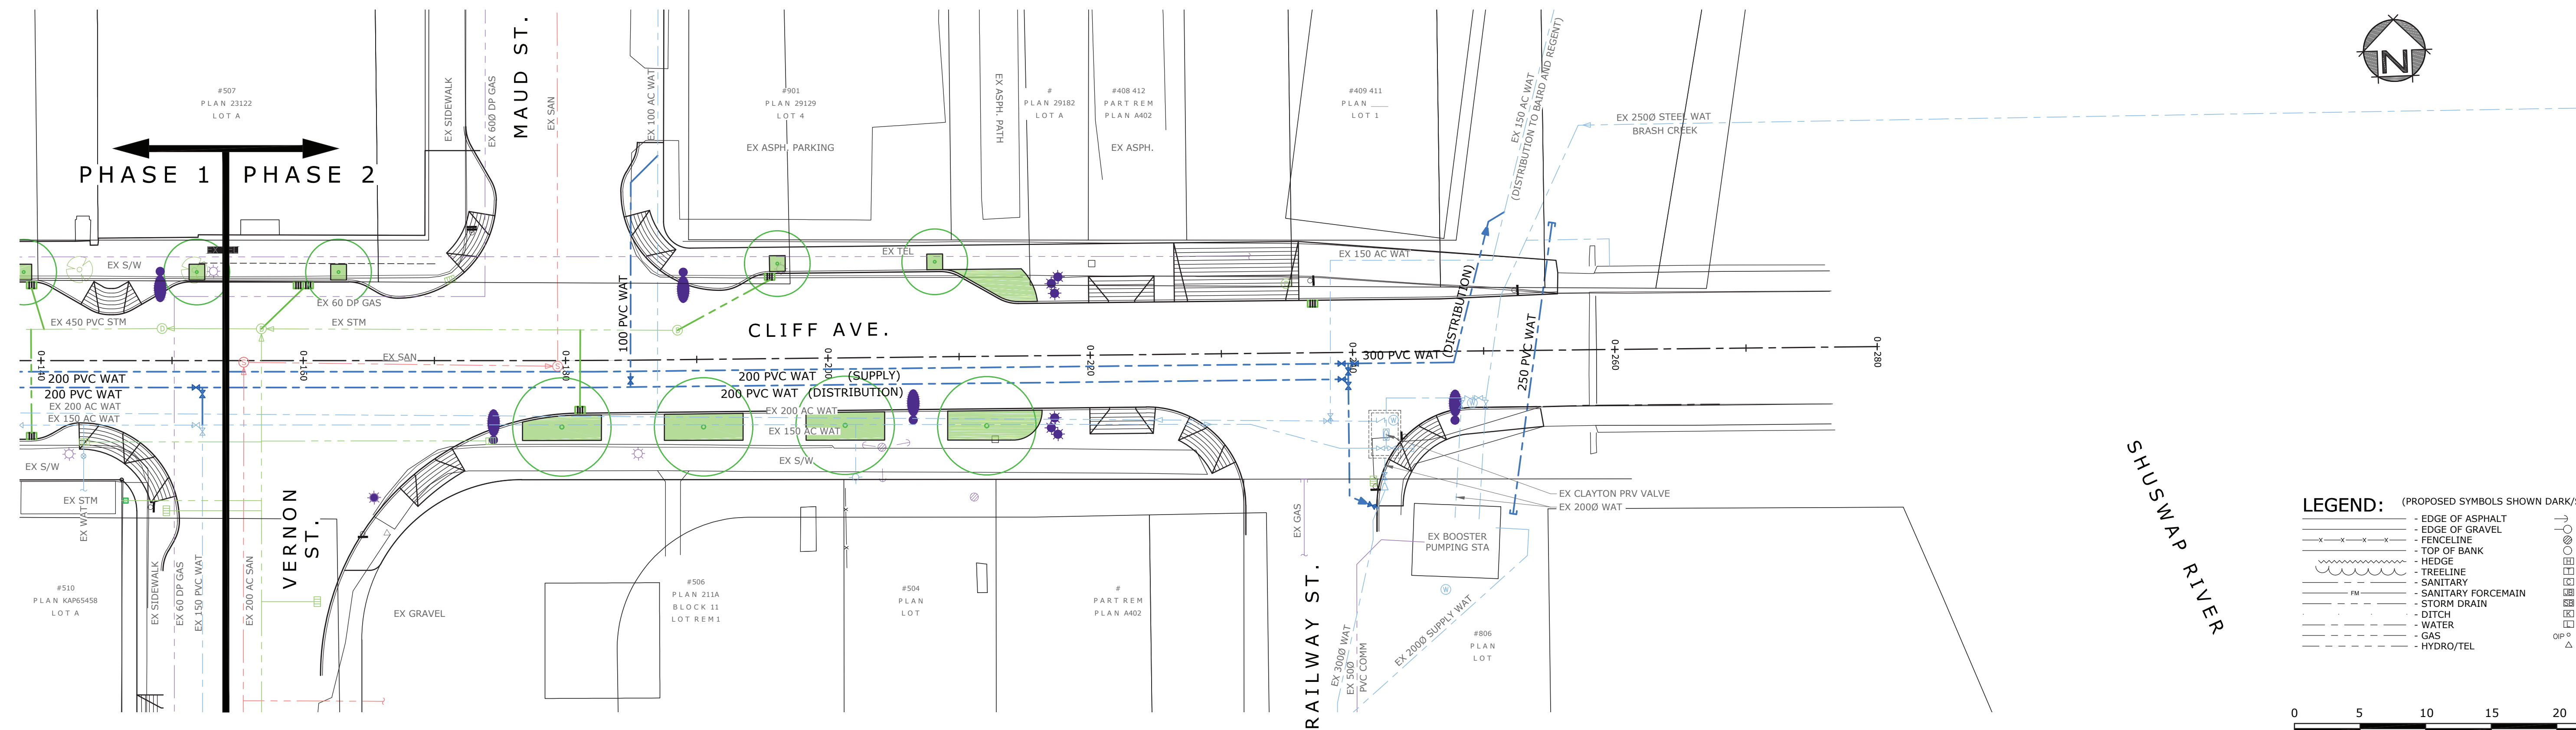

CIVIL UTILITY PLAN

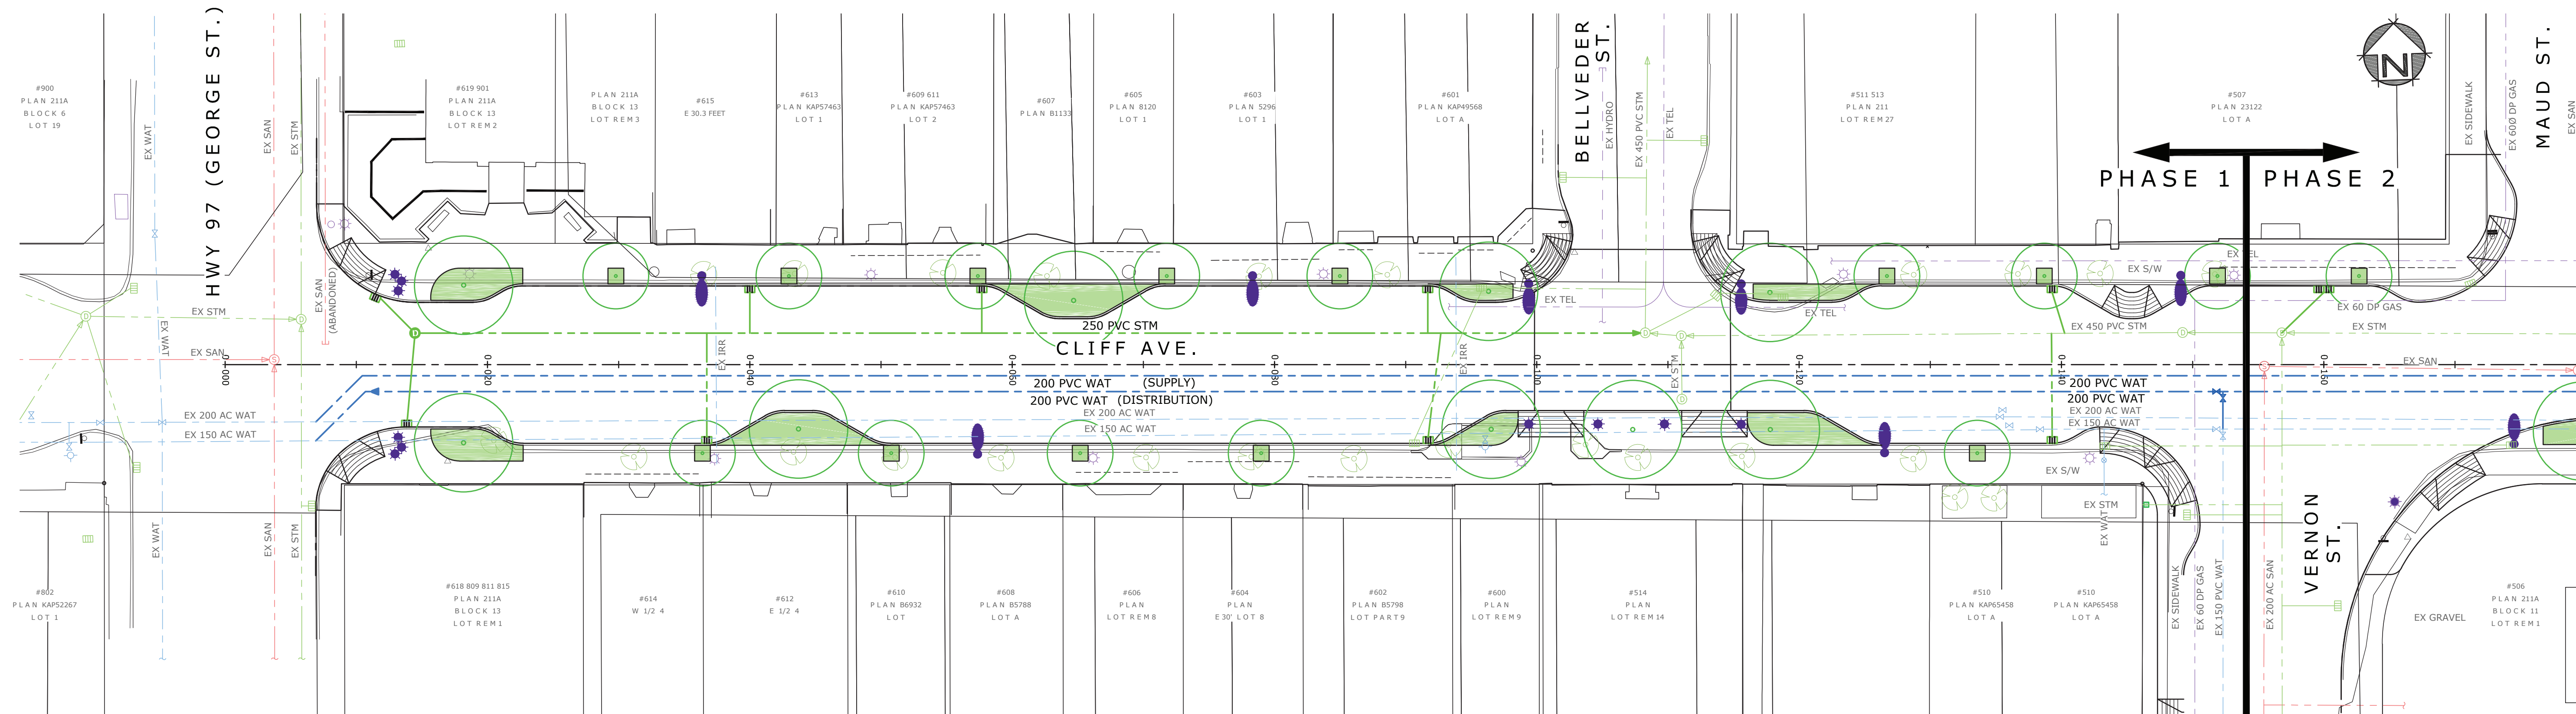

LEGEND: (PROPOSED SYMBOLS SHOWN DARK/SOLID)

- EDGE OF ASPHALT	- GUY WIRE	- PIPE INVERT
- EDGE OF GRAVEL	- ANCHOR POLE	- WATER MANHOLE
- FENCELINE	- HYDRO POLE	- WATER VALVE
- TOP OF BANK	- TEL POLE	- CURB STOP
- HEDGE	- HYDRO VAULT	- FIRE HYDRANT
- TREELINE	- TEL VAULT	- BLOW-OFF
- SANITARY	- SAN. CABLE VAULT	
- SANITARY FORCEMAIN	- JUNCTION BOX	
- STORM DRAIN	- SERVICE BOX	
- DITCH	- KIOSK	
- GAS	- LIFT	
- HYDRO/TEL	- PROPERTY PIN	
	- HUB	

GEODETIC MONUMENT

- SIGN
- CEDAR SHRUB
- CAP
- REDUCER
- SANITARY CLEANOUT
- SAN. INSPECTION CHAMBER
- DRAIN CLEANOUT
- DRAIN INSPECTION CHAMBER
- CATCHBASIN MANHOLE
- CATCHBASIN
- HEADWALL

SCALE: 1:250

0 5 10 15 20 25